

 
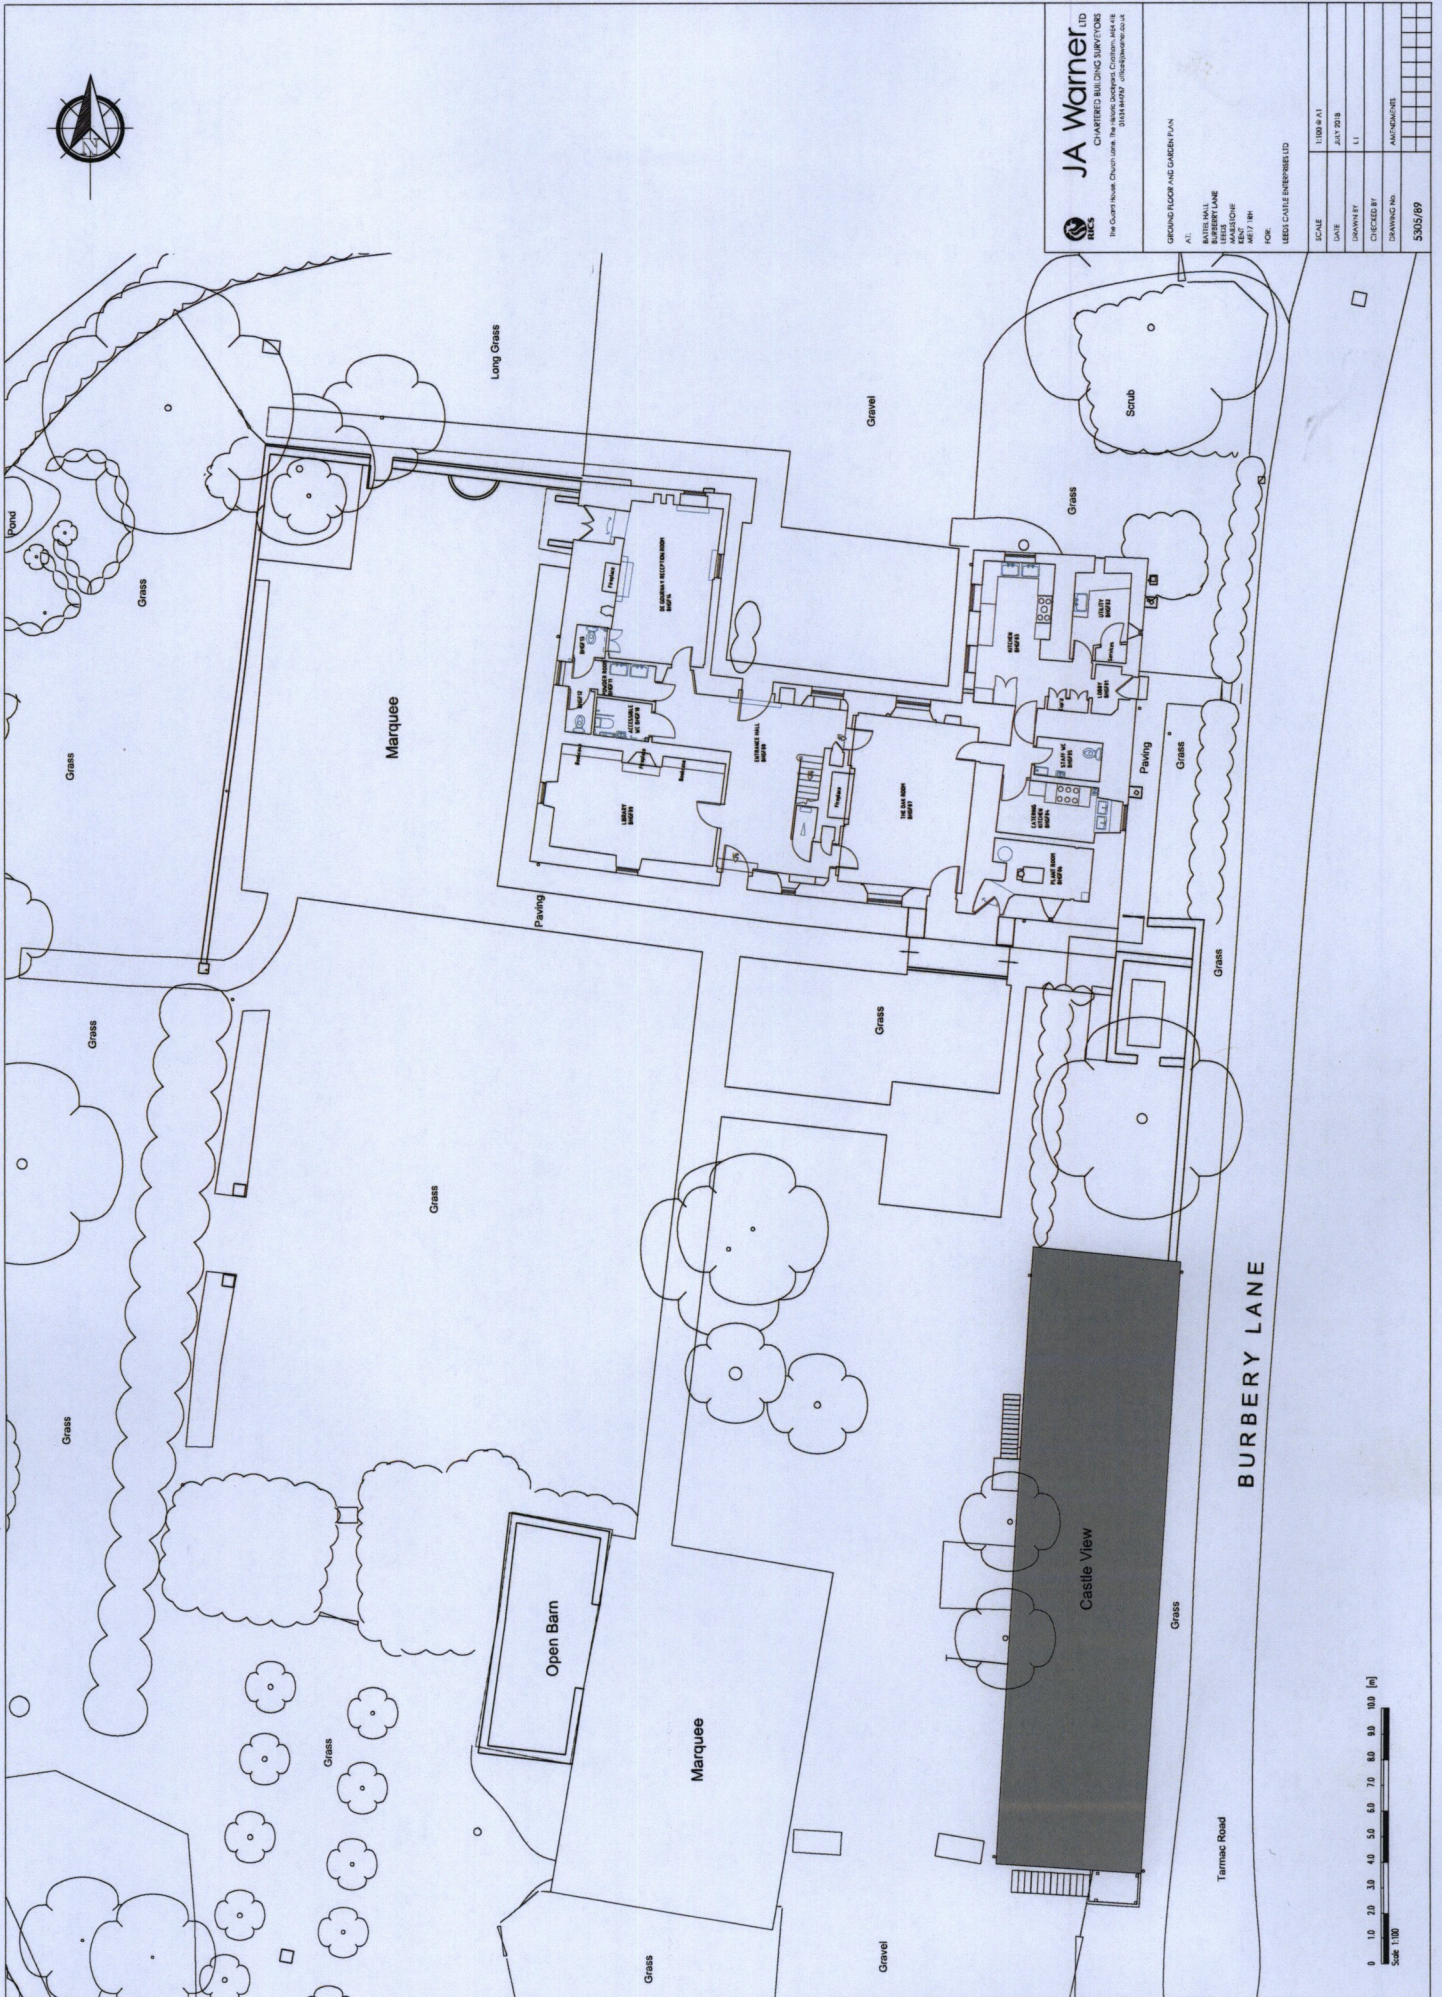


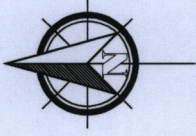



LEGEND

-  fire escape directional signage
-  fire blanket
-  CO₂ fire extinguisher
-  water fire extinguisher

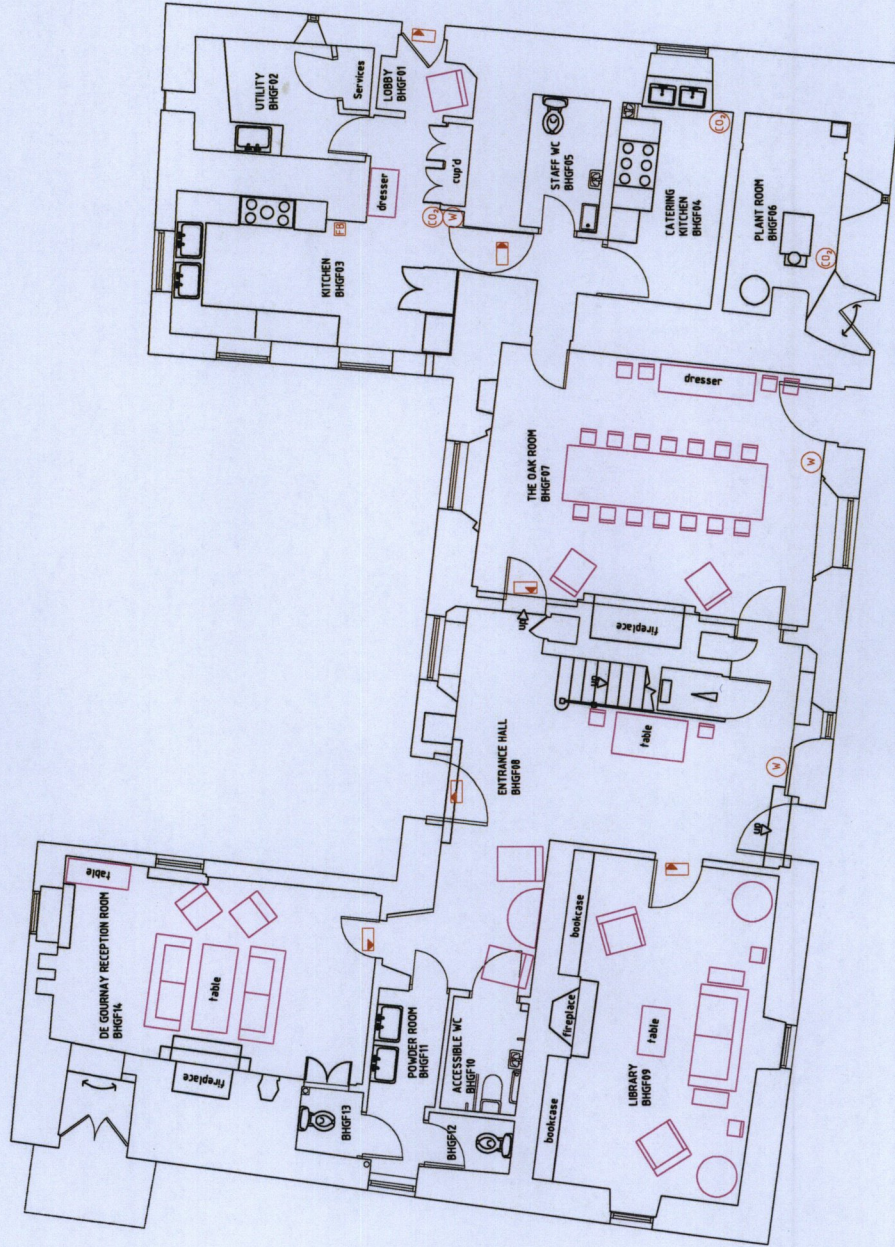

JA Warner LTD

CHARTERED BUILDING SURVEYORS

The Guard House, Church Lane, The Historic Dockyard, Chatham, ME4 4TE
01634 844767 office@jawnarner.co.uk

GROUND FLOOR PLAN

AT:

BATTEL HALL
BURBERRY LANE
LEEDS
MAIDSTONE
KENT
ME17 1RH

FOR:

LEEDS CASTLE ENTERPRISES LTD

SCALE 1:100 @ A3


DATE JULY 2018

DRAWN BY LI

CHECKED BY

DRAWING No. AMENDMENTS

5305/90

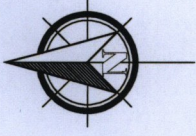

LEGEND

fire escape directional signage

fire blanket

CO₂ fire extinguisher

water fire extinguisher



JA Warner LTD

CHARTERED BUILDING SURVEYORS

The Guard House, Church Lane, The Historic Dockyard, Chatham, ME4 4TE
01634 844767 office@jawnarner.co.uk

FIRST FLOOR PLAN

AT:

BATTEL HALL
BURBERRY LANE
LEEDS
MAIDSTONE
KENT
ME17 1RH

FOR:

LEEDS CASTLE ENTERPRISES LTD

SCALE

1:100 @ A3

DATE

JULY 2018

DRAWN BY

LI

CHECKED BY

AMENDMENTS

DRAWING No.

5305/91

